

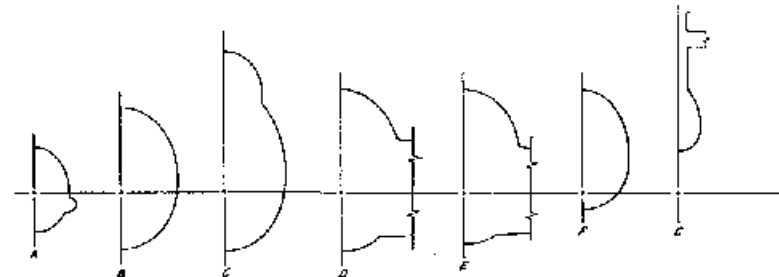
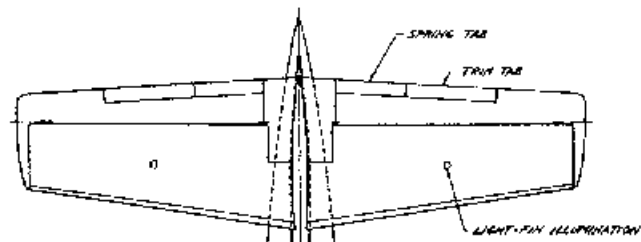
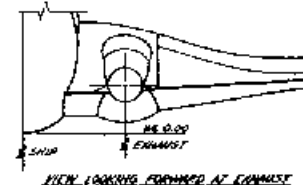
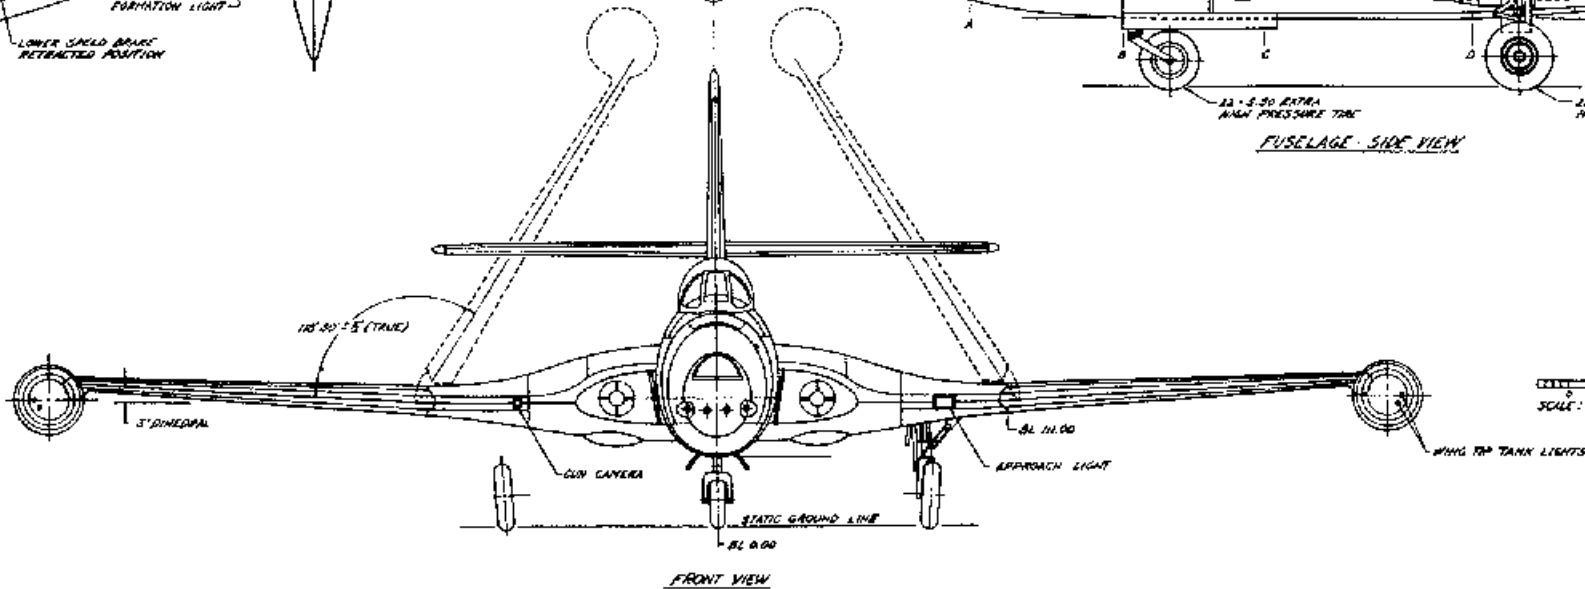
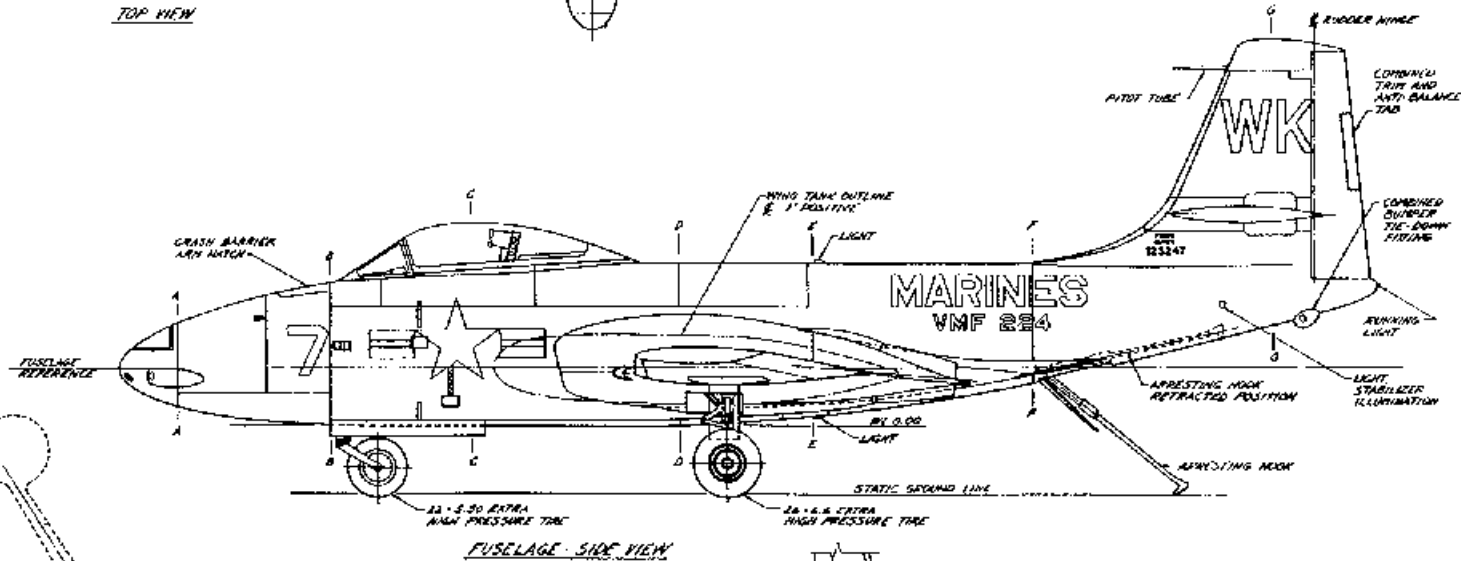
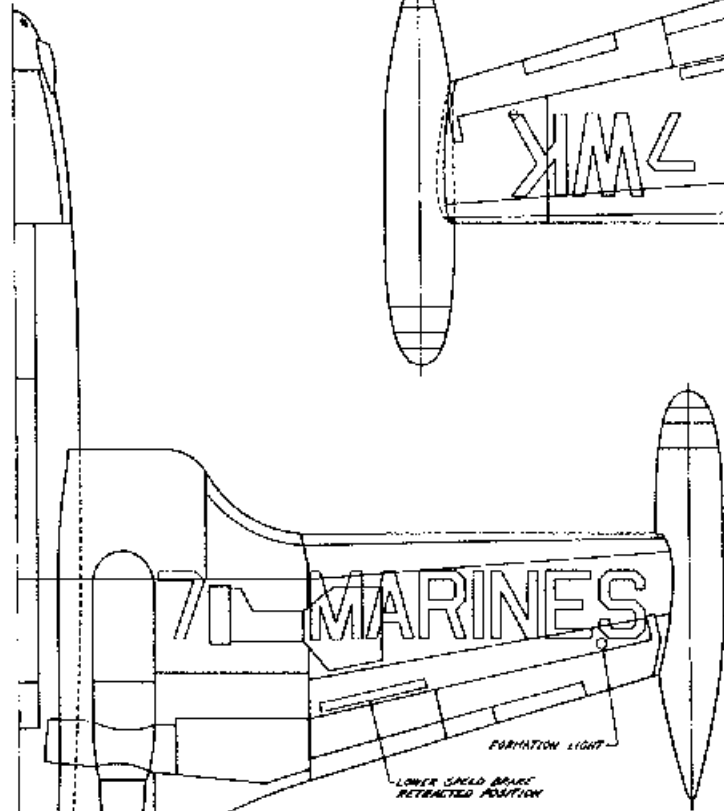


AIRPLANE SPECIFICATIONS

WINGSSPAN WITH TIP TANKS	44 FT. 11.90 IN.
WINGSSPAN WITHOUT TIP TANKS	41 FT. 8.64 IN.
LENGTH	40 FT. 8.63 IN.
HEIGHT	19 FT. 5.30 IN.
HEIGHT OVER CANOPY	8 FT. 5.35 IN.
HORIZONTAL TAIL SPAN	18 FT. 9.37 IN.
FUSELAGE DEPTH	5 FT. 1.50 IN.
TRAIL	13 FT. 6.06 IN.
FUSELAGE 100% FROM STATIC GND LINE	8 FT. 2.50 IN.
WEIGHT - EMPTY	11146 LBS.
WEIGHT - MAXIMUM TAKE OFF	23313 LBS.
SPEED - MAXIMUM	373 MPH
SERVICE CEILING	44800 FT.
RANGE	4000 MILES
POWER PLANT	121 WESTINGHOUSE J-30 W/T 3150 LBS. THRUST
ARMAMENT	141.20 MPH GANNON

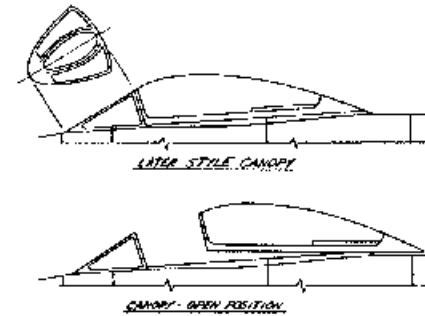

AIRFOIL AT 24 THRU MACI 0.5 ETC. - 8' INCIDENCE
 AIRFOIL AT WING TIP MACI 0.05 - 8' INCIDENCE "W-W"
 TYPICAL HORIZONTAL AND VERTICAL STABILIZER AIRFOIL, MACI 0.5-0.7
 HORIZONTAL TAIL INCIDENCE, 10° 25'

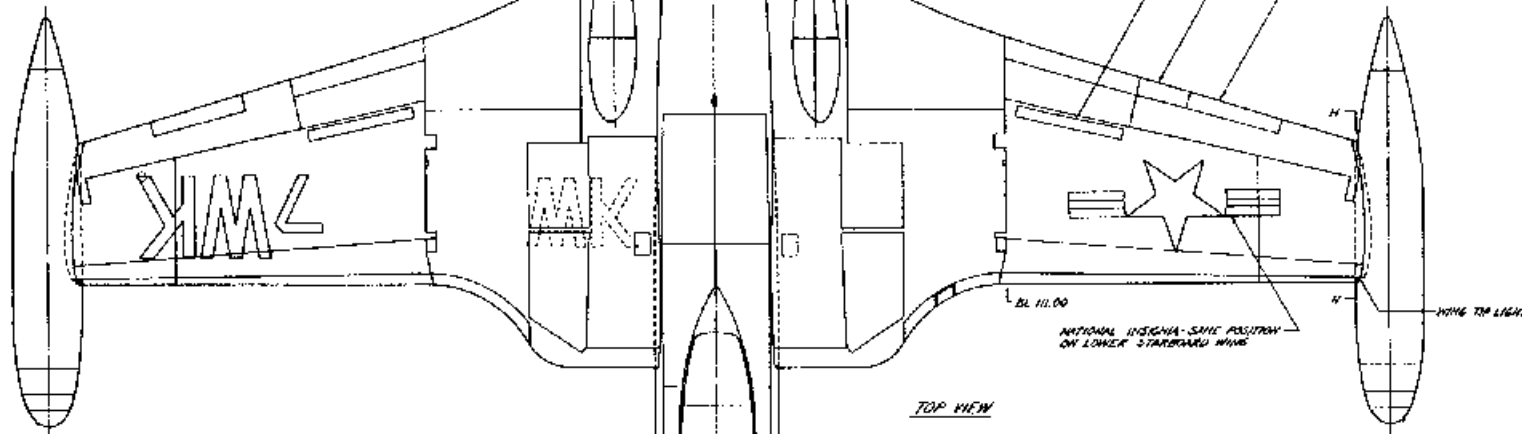

SCALE: 1/4" = 1 FT. 0 IN.

REFERENCE:
 1. HEDDENWELL AIRCRAFT CORP. DRAWING NO. 15-0007
 2. HAWK PARTS AND ACCESSORIES, HEDDENWELL AIRCRAFT CORP.
 3. AIRCRAFT SCALE MODEL, AIRCRAFT CORP.
 4. UNITED STATES ARMY AIR MUSEUM, WRIGHT PATTENSON AIR FORCE MUSEUM, WRIGHT PATTENSON AIR FORCE MUSEUM, WRIGHT PATTENSON AIR FORCE MUSEUM
 5. U.S. FIGHTERS OF THE PAST, WACO, TEXAS, TEXAS

HEDDENWELL AIRCRAFT CORP., SAINT LOUIS, MISSOURI, USA
F2H-2 AIRPLANE
 DRAWN BY JOHN W. BELL, 1993 SCALE: 1/4" = 1 FT. 0 IN.
 BELL MODEL AIRCRAFT CO.
 650 PINE CREST DRIVE, LARGO, FLORIDA, USA 32750-2003